


**SAMPLE DRAWINGS**  
**NEW HOME**  
**CONSTRUCTION**


NOTES:  
**ALL TYPICAL CONSTRUCTION SHALL CONFORM TO THE O.B.C. PART 9 (MOST CURRENT EDITION AND AMENDMENTS)**

- 1- MECHANICAL & ELECTRICAL DESIGN BY CONTRACTOR
- 2- ALL FLOOR DRAIN LOCATIONS TO BE VERIFIED BY CONTRACTOR
- 3- ALL "B" - VENT LOCATIONS TO BE VERIFIED BY CONTRACTOR
- 4- ALL ROOF ATTIC AREAS MUST HAVE ACCESS.
- 5- ALL STAIRS TO BE APPROVED BY WAY OF SHOP DRAWINGS PRIOR TO MANUFACTURING.
- 6- ALL KITCHEN CABINETS TO BE APPROVED PRIOR TO MANUFACTURING BY WAY OF SHOP DRAWING BY THE SUPPLIER.
- 7- KITCHEN PLAN LAYOUT TO BE APPROVED BY OWNER AND KITCHEN DESIGNER PRIOR TO MANUFACTURING & INSTALLATION.
- 8- ALL ELECTRICAL LAYOUT TO BE VERIFIED ON SITE WITH OWNER/BUILDER & CONTRACTOR.
- 9- ROOF LAYOUT & GIRDER TRUSS LOCATIONS TO BE VERIFIED BY ROOF TRUSS MANUFACTURER PRIOR TO MANUFACTURING.


ALL CONTRACTORS AND/OR TRADES SHALL VERIFY ALL DIMENSIONS, NOTES, SITE AND REPORT ANY DISCREPANCIES PRIOR TO COMMENCEMENT OF WORK. THIS DRAWING IS NOT TO BE SCALED. ALL DRAWINGS, PRINTS AND RELATED DOCUMENTS ARE THE PROPERTY OF THE DESIGNER AND MUST BE RETURNED UPON REQUEST. REPRODUCTION OF DRAWINGS AND RELATED DOCUMENTS IN PART OR IN WHOLE IS STRICTLY FORBIDDEN WITHOUT WRITTEN CONSENT. DRAWINGS TO BE USED FOR THE PURPOSE FOR WHICH THEY ARE ISSUED.

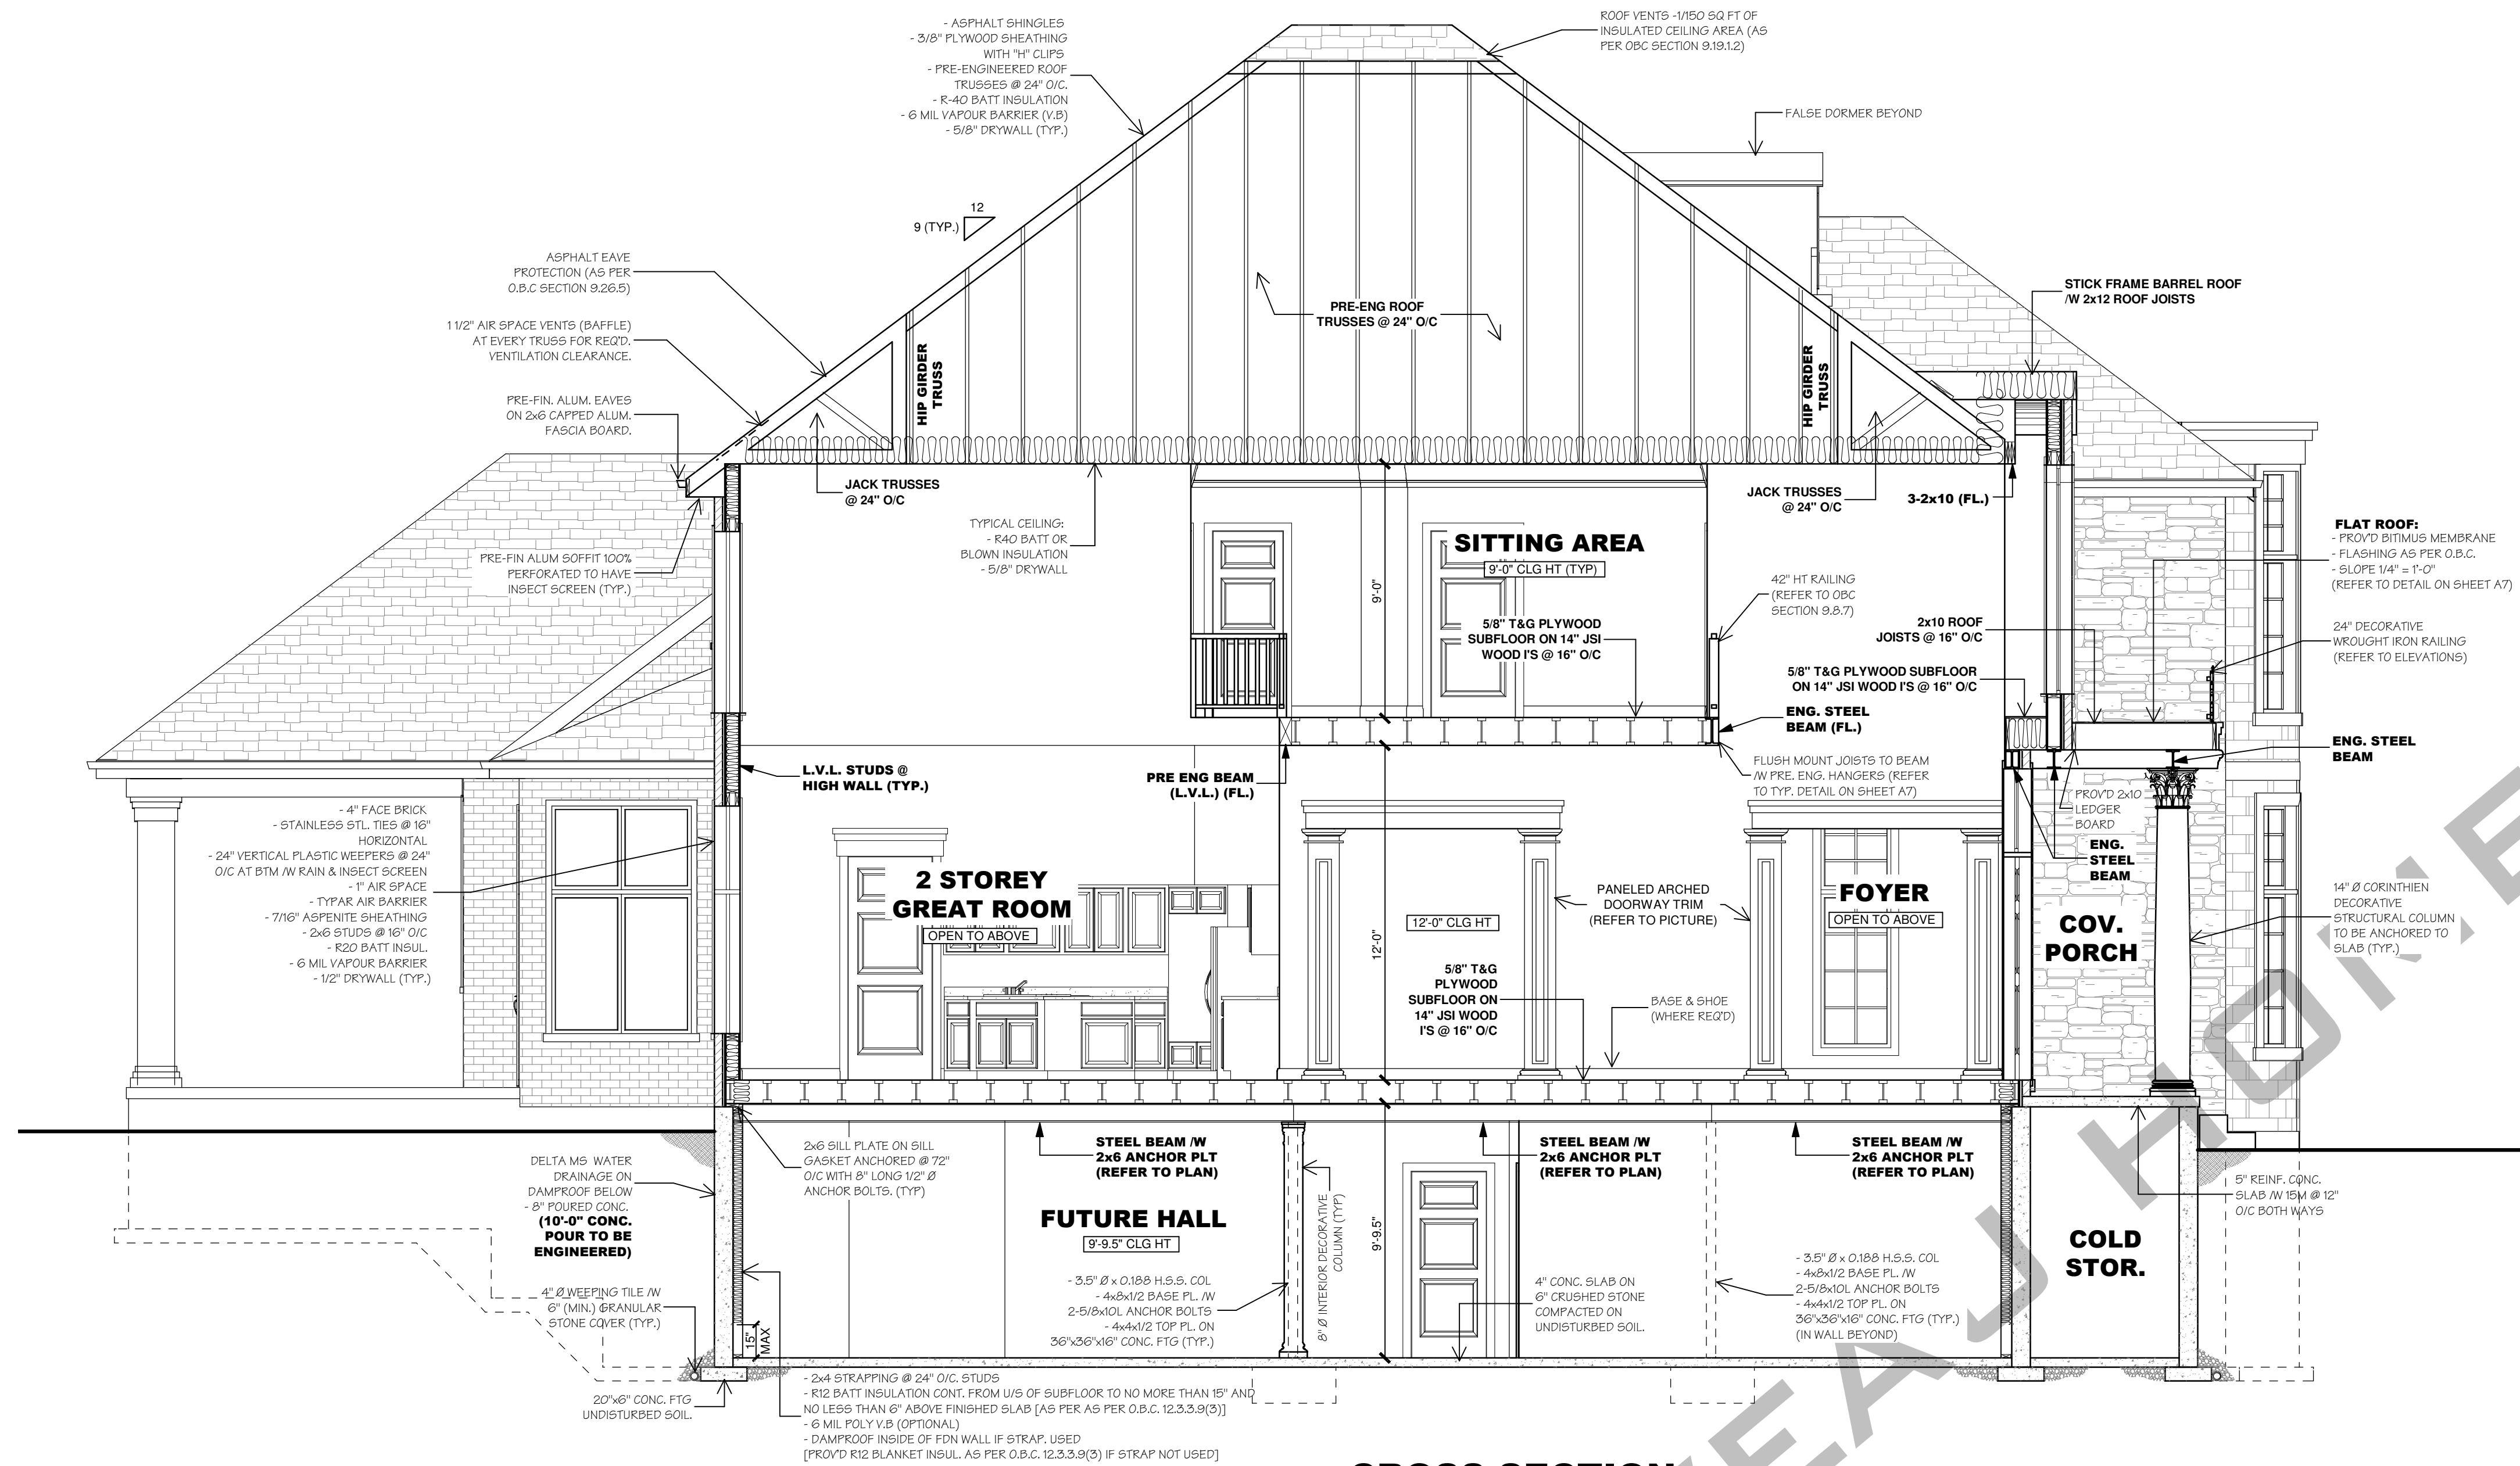


**CROSS SECTION**  
 SCALE: 1/4" = 1'-0"

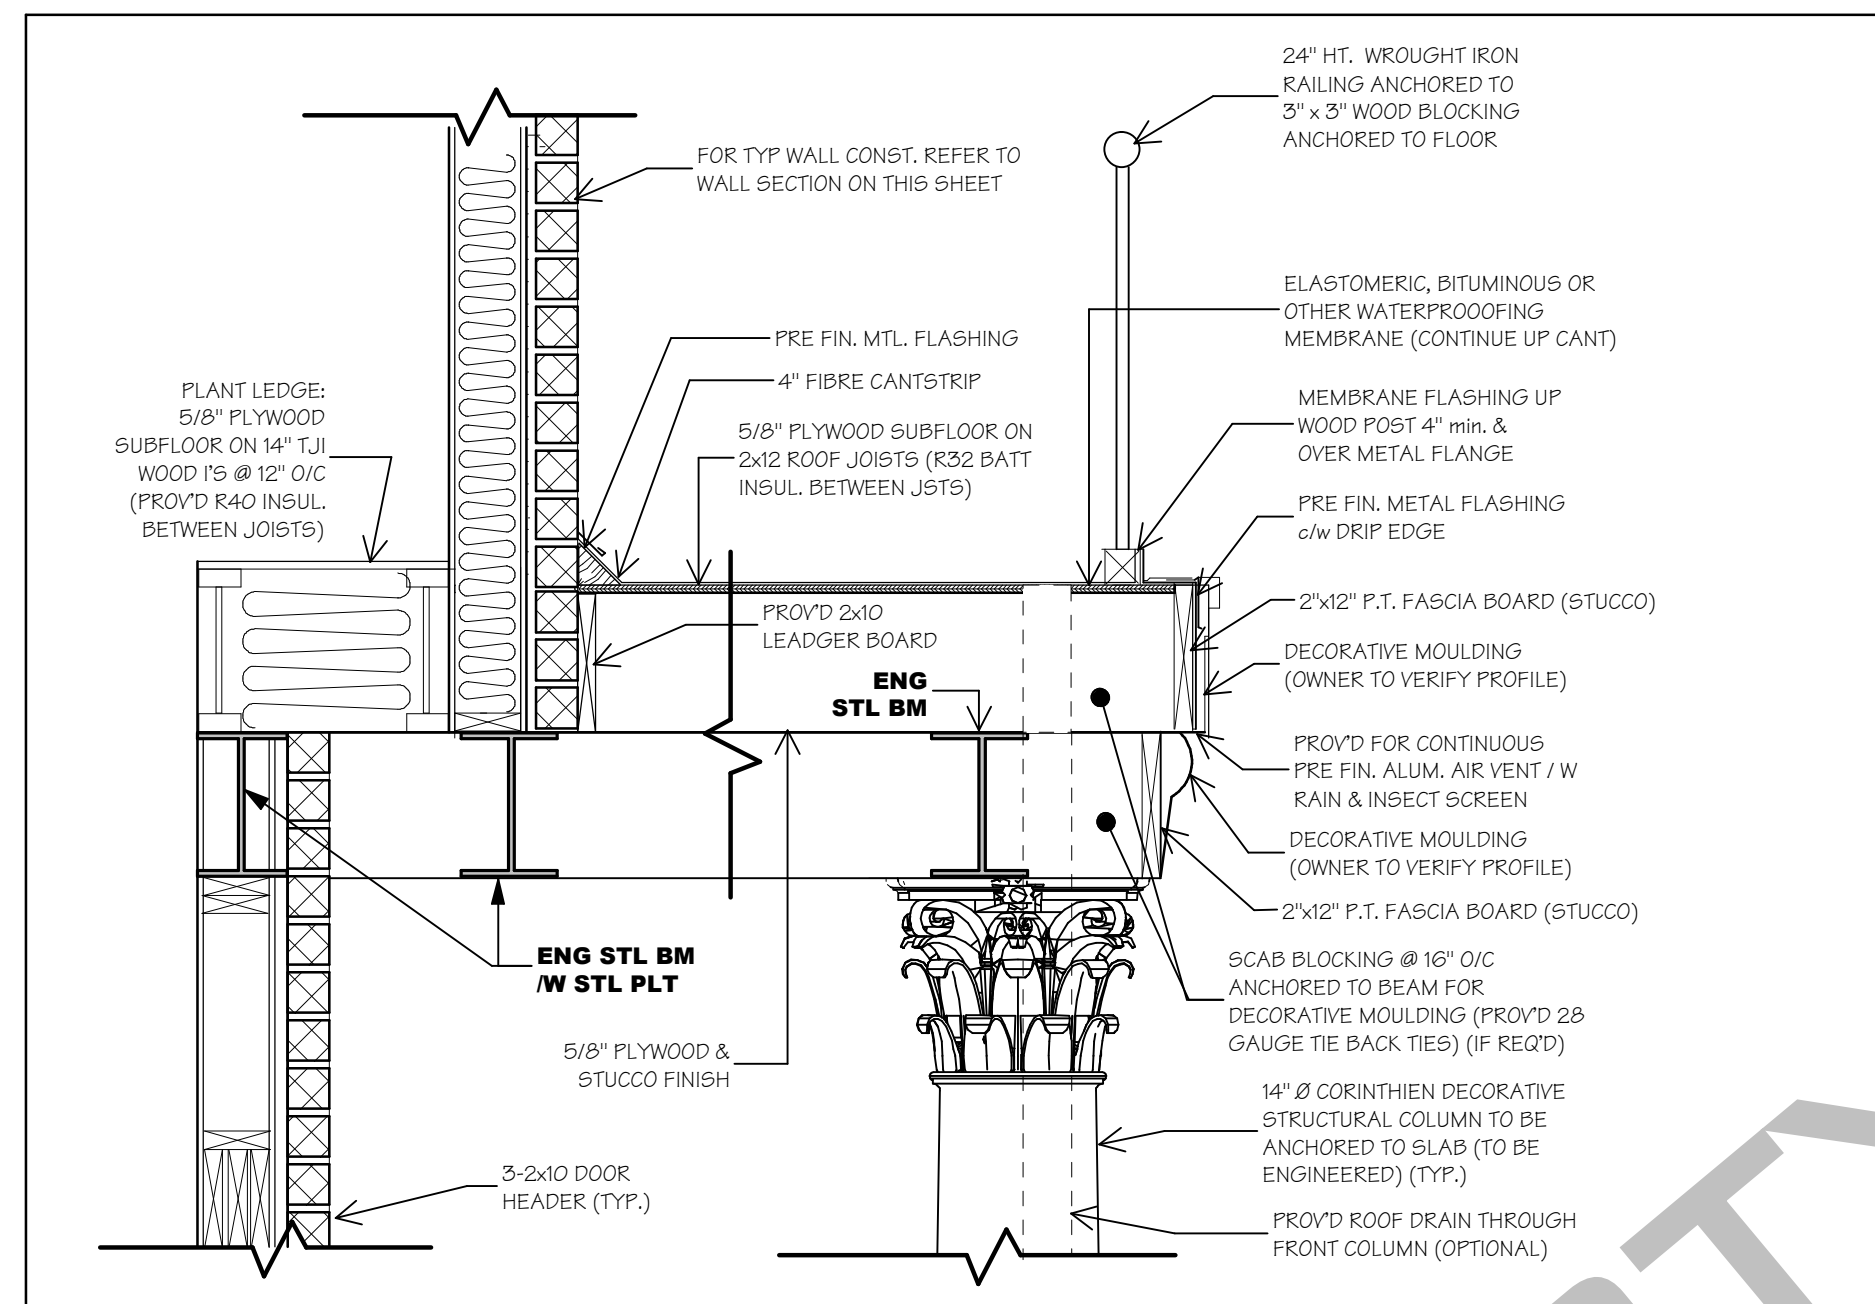


**TYP. FLAT ROOF DETAIL**  
 SCALE: 3/4" = 1'-0"

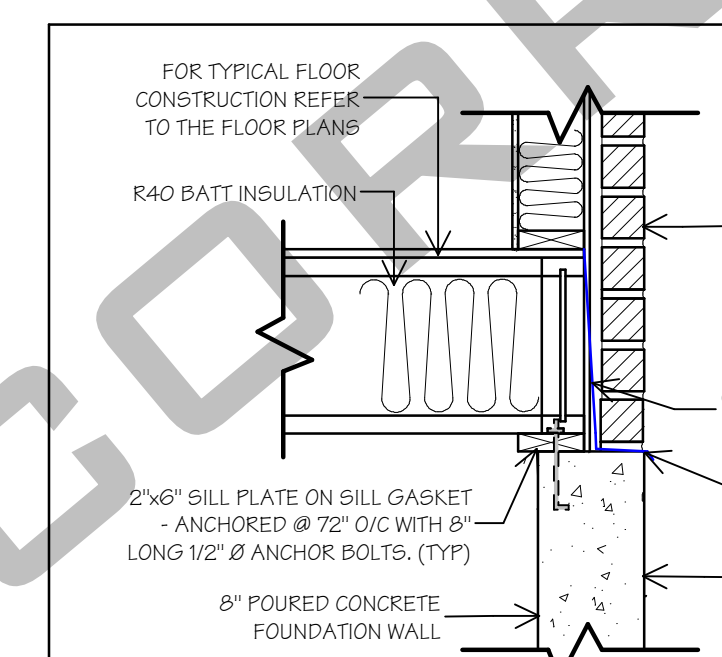


**TYP. JST TO FDN DETAIL**  
 SCALE: 3/4" = 1'-0"

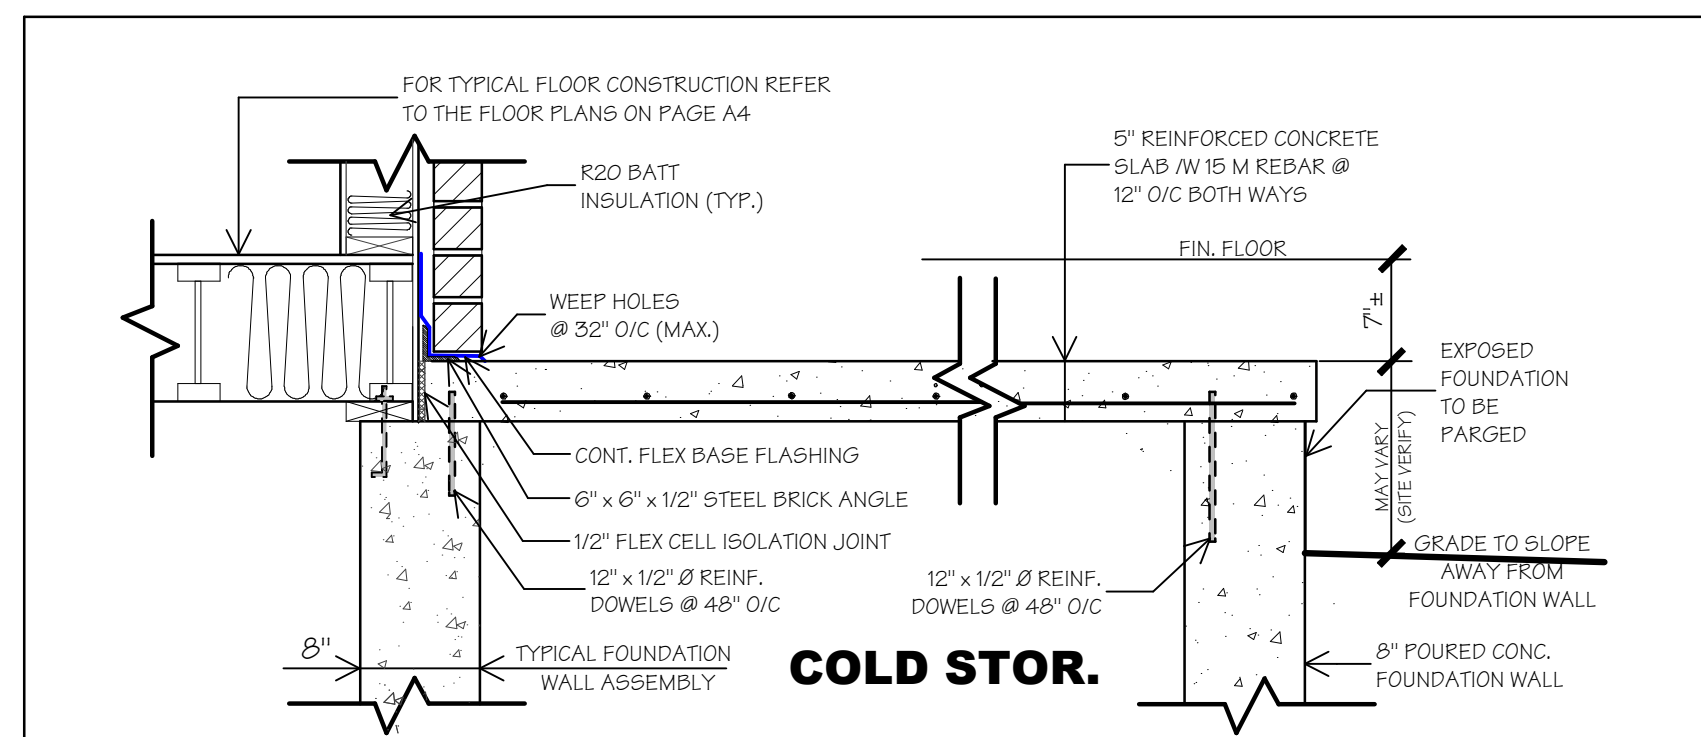


**TYP. PORCH SLAB DETAIL**  
 SCALE: 3/4" = 1'-0"

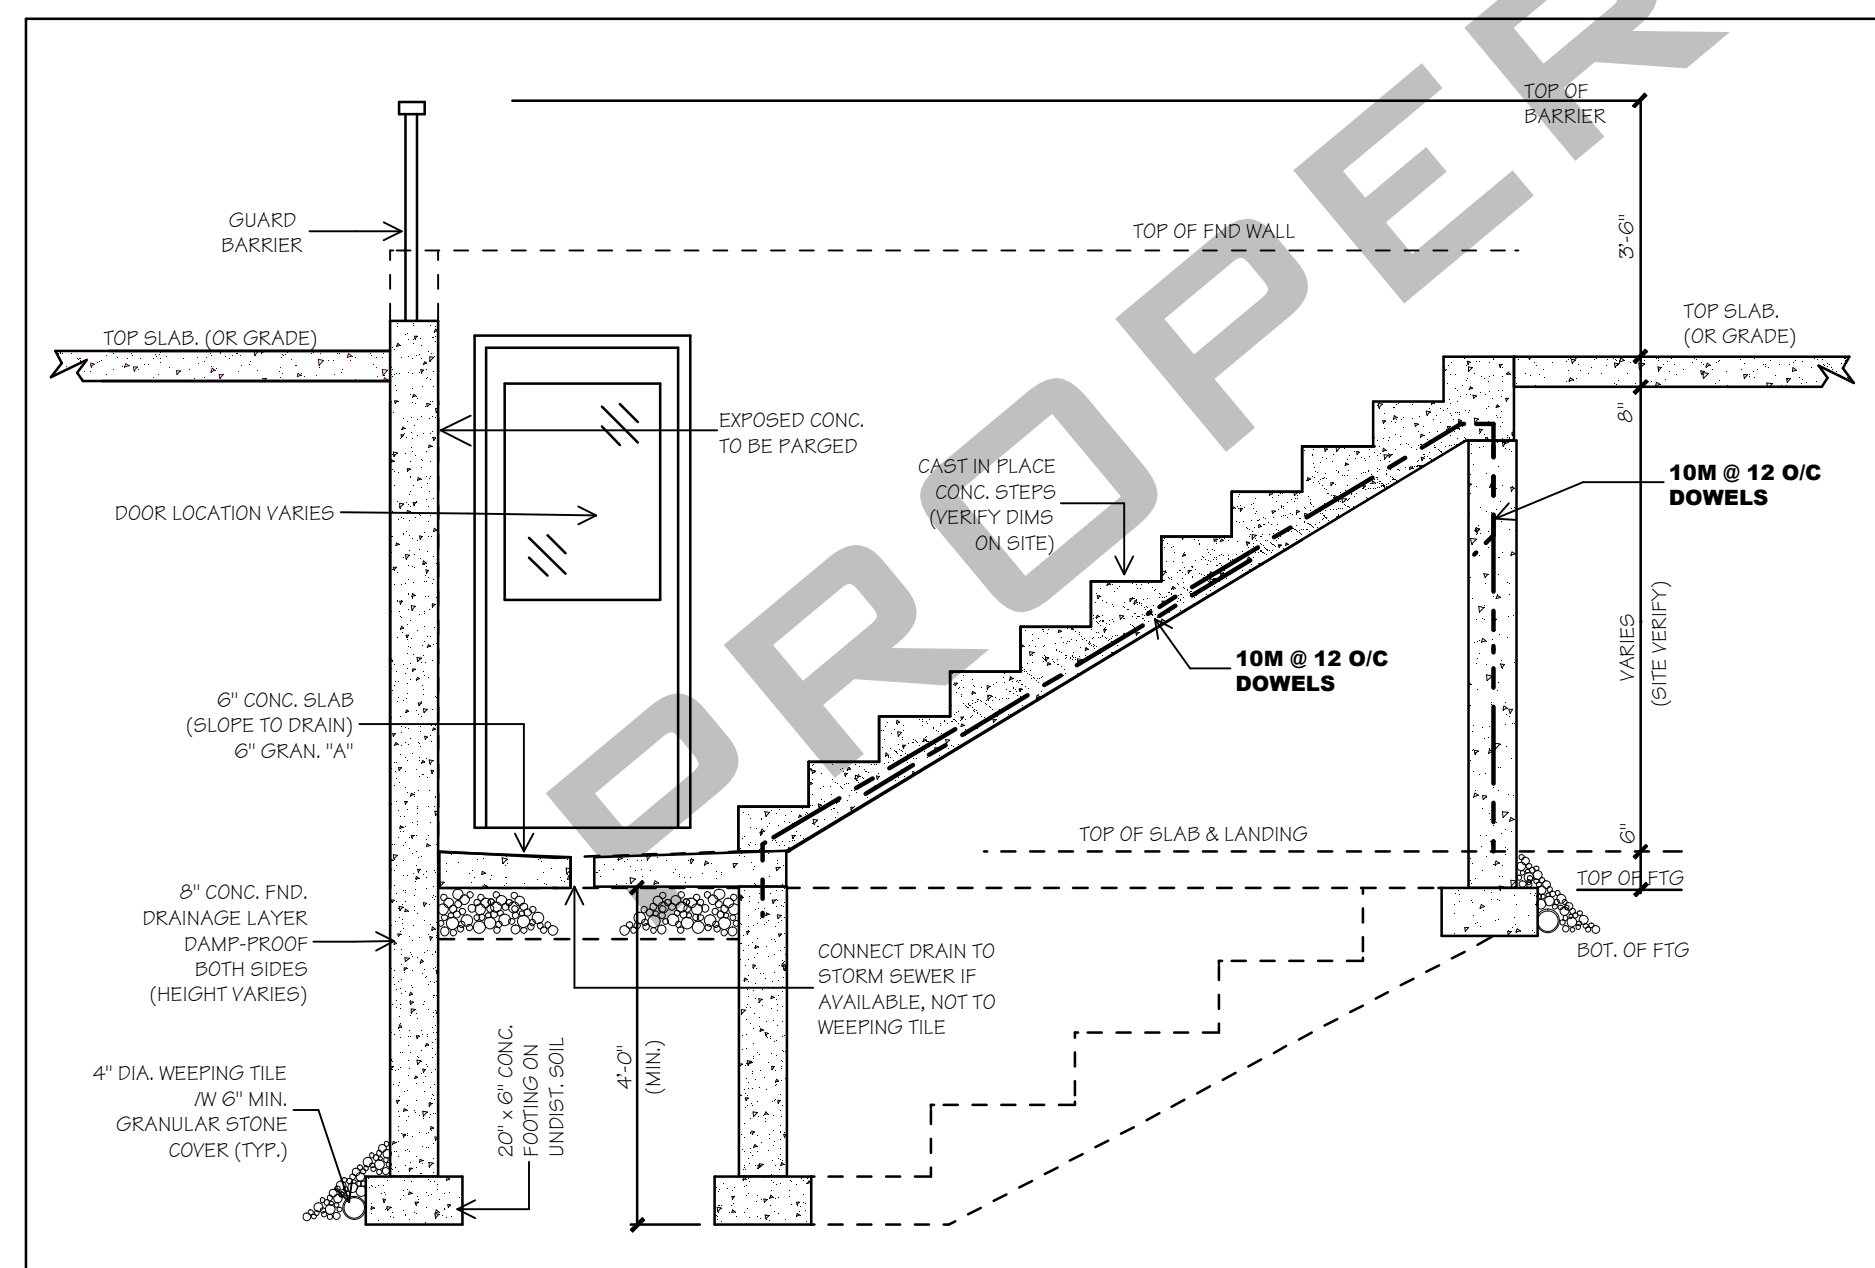


**TYP. CONC STAIR WALKOUT DETAIL**  
 SCALE: 3/8" = 1'-0"

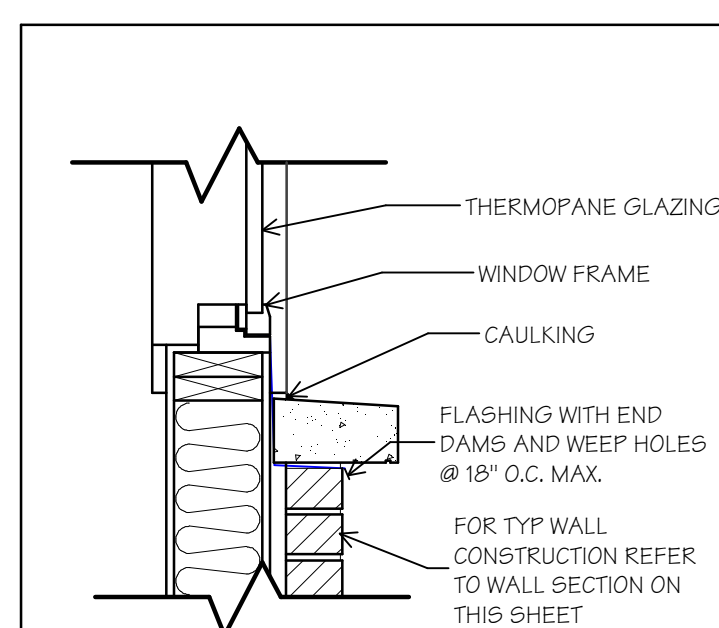

**TYP. WIN. SILL**  
 SCALE: 1" = 1'-0"

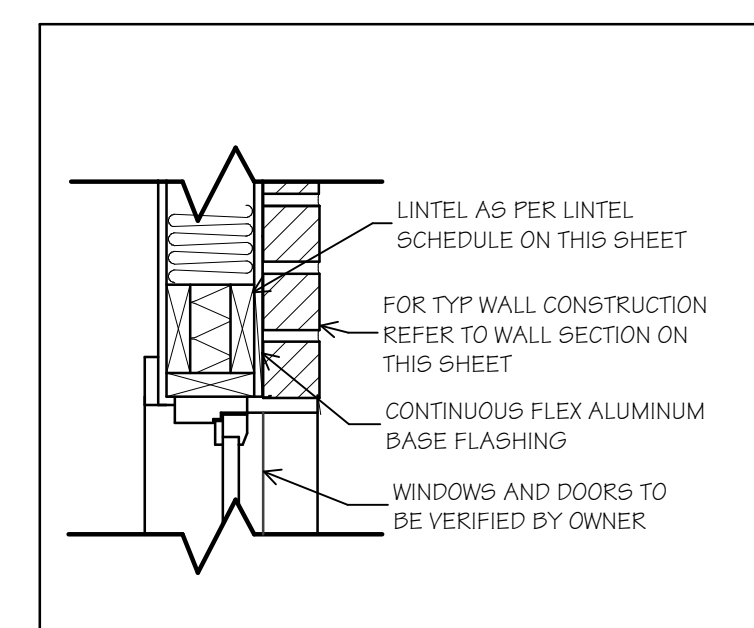

**TYP. HEADER**  
 SCALE: 1" = 1'-0"

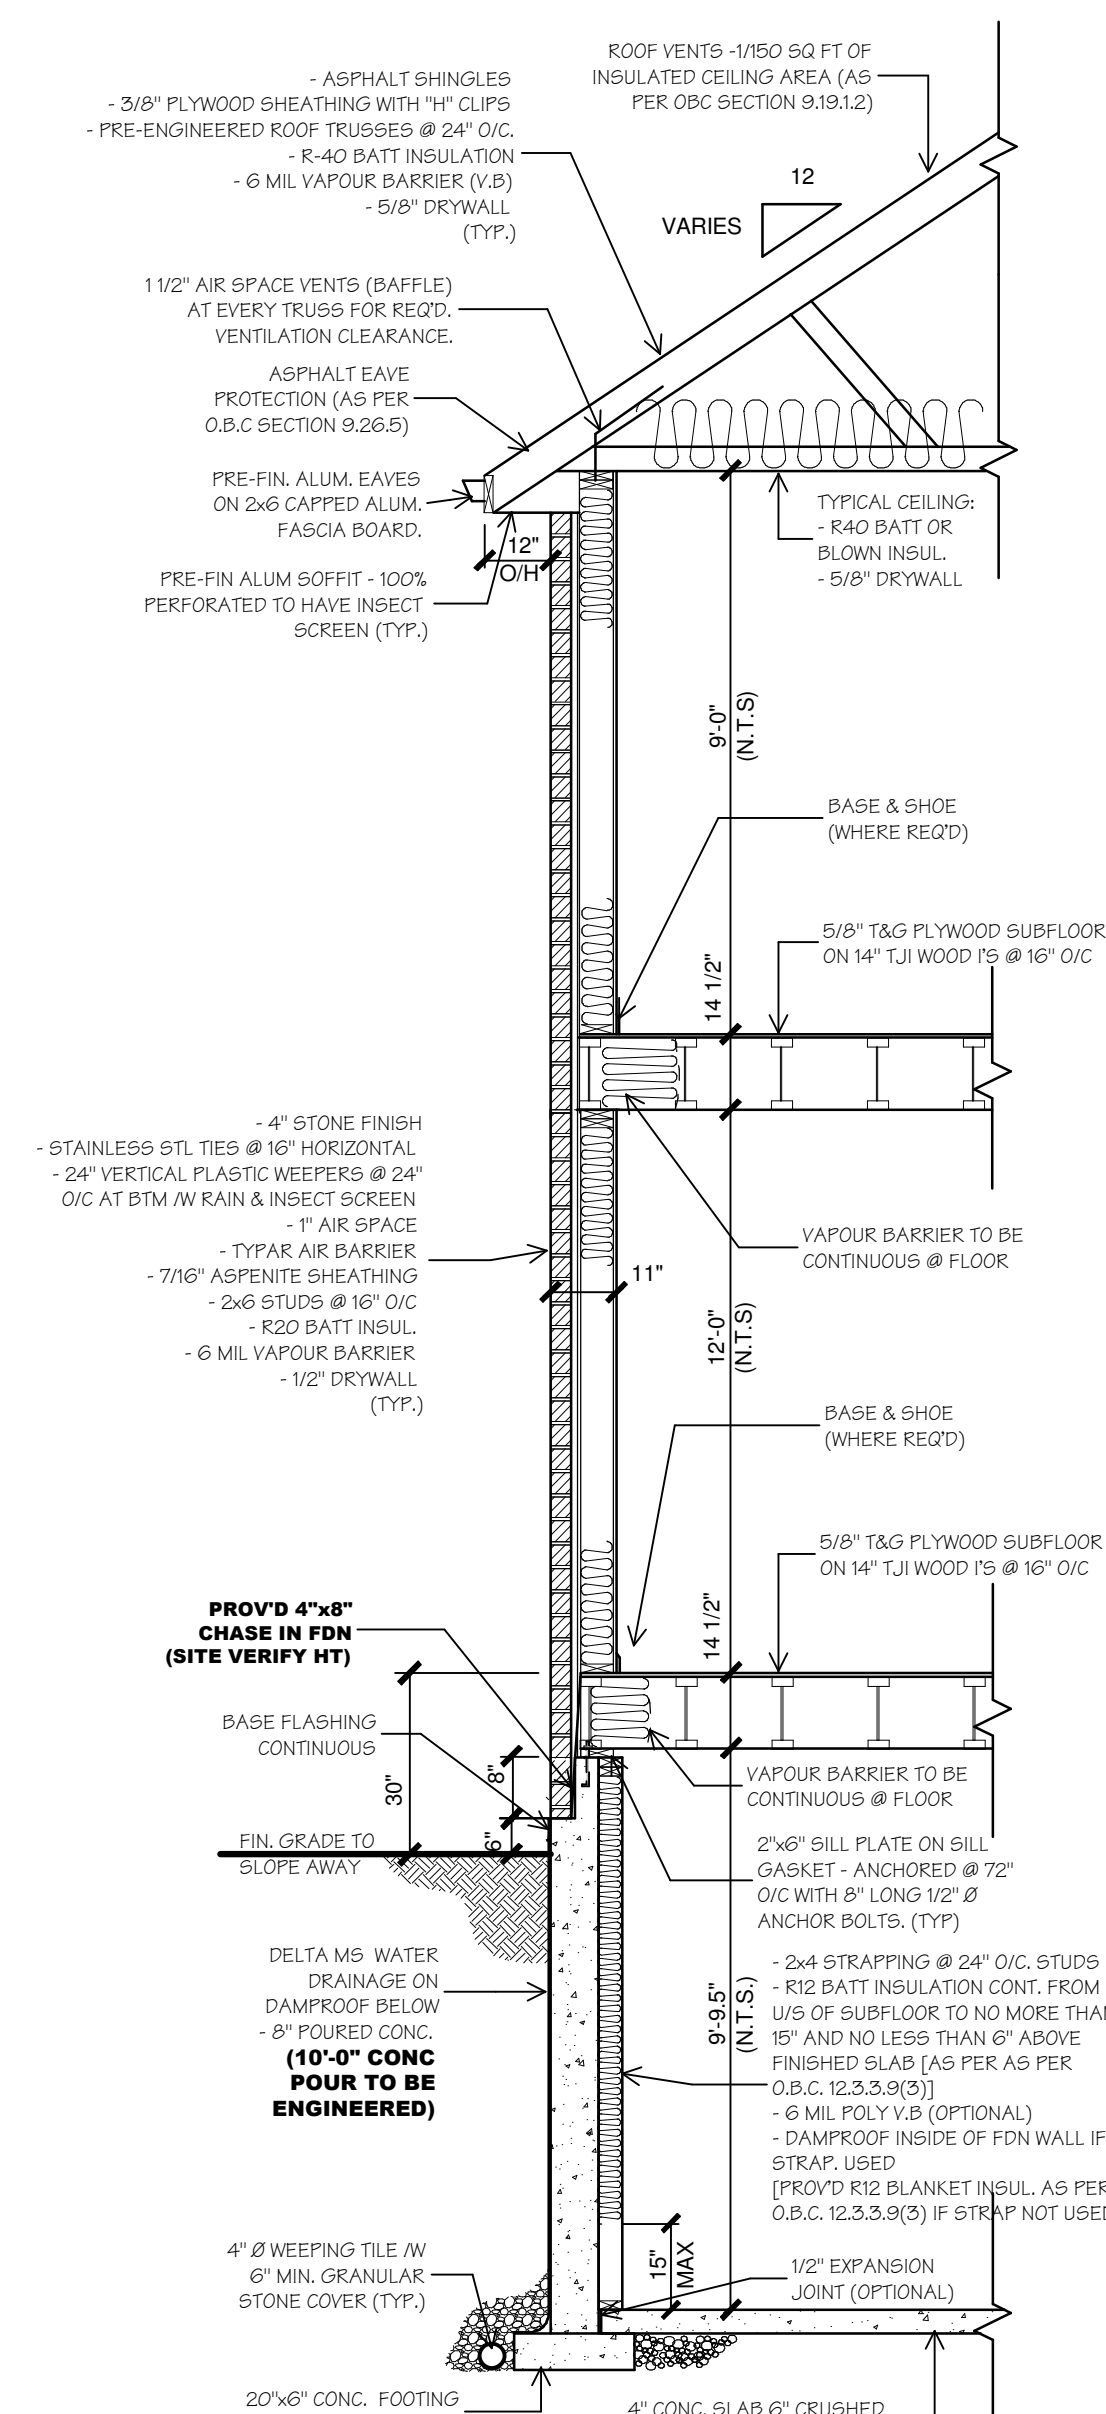

**WALL SECTION**  
 SCALE: 1/2" = 1'-0"

| NO. | DATE: | REVISION: | BY |
|-----|-------|-----------|----|
|     |       |           |    |
|     |       |           |    |
**CERTIFICATION:**

DR. BY:

CH. BY:

DATE:

SCALE:

TITLE: